

NOTE: ALL DIMENSIONS AND INFORMATION TO BE CONFIRMED ON SITE BY CONTRACTOR

Address: **Kenepuru Subdivision**  
**Proposed 3 Bedroom Stand-Alone**

Drawing: **Lot 142 - Proposed New Dwelling**  
Gross Floor Area: 127.128m<sup>2</sup>


 
Drawn Date:  
10.09.2018

Drawn By:  
J. Clegg

Checked By:  
101 Homes

Drawn Scale:  
1 : 100

Sheet No:  
Revision: **000**

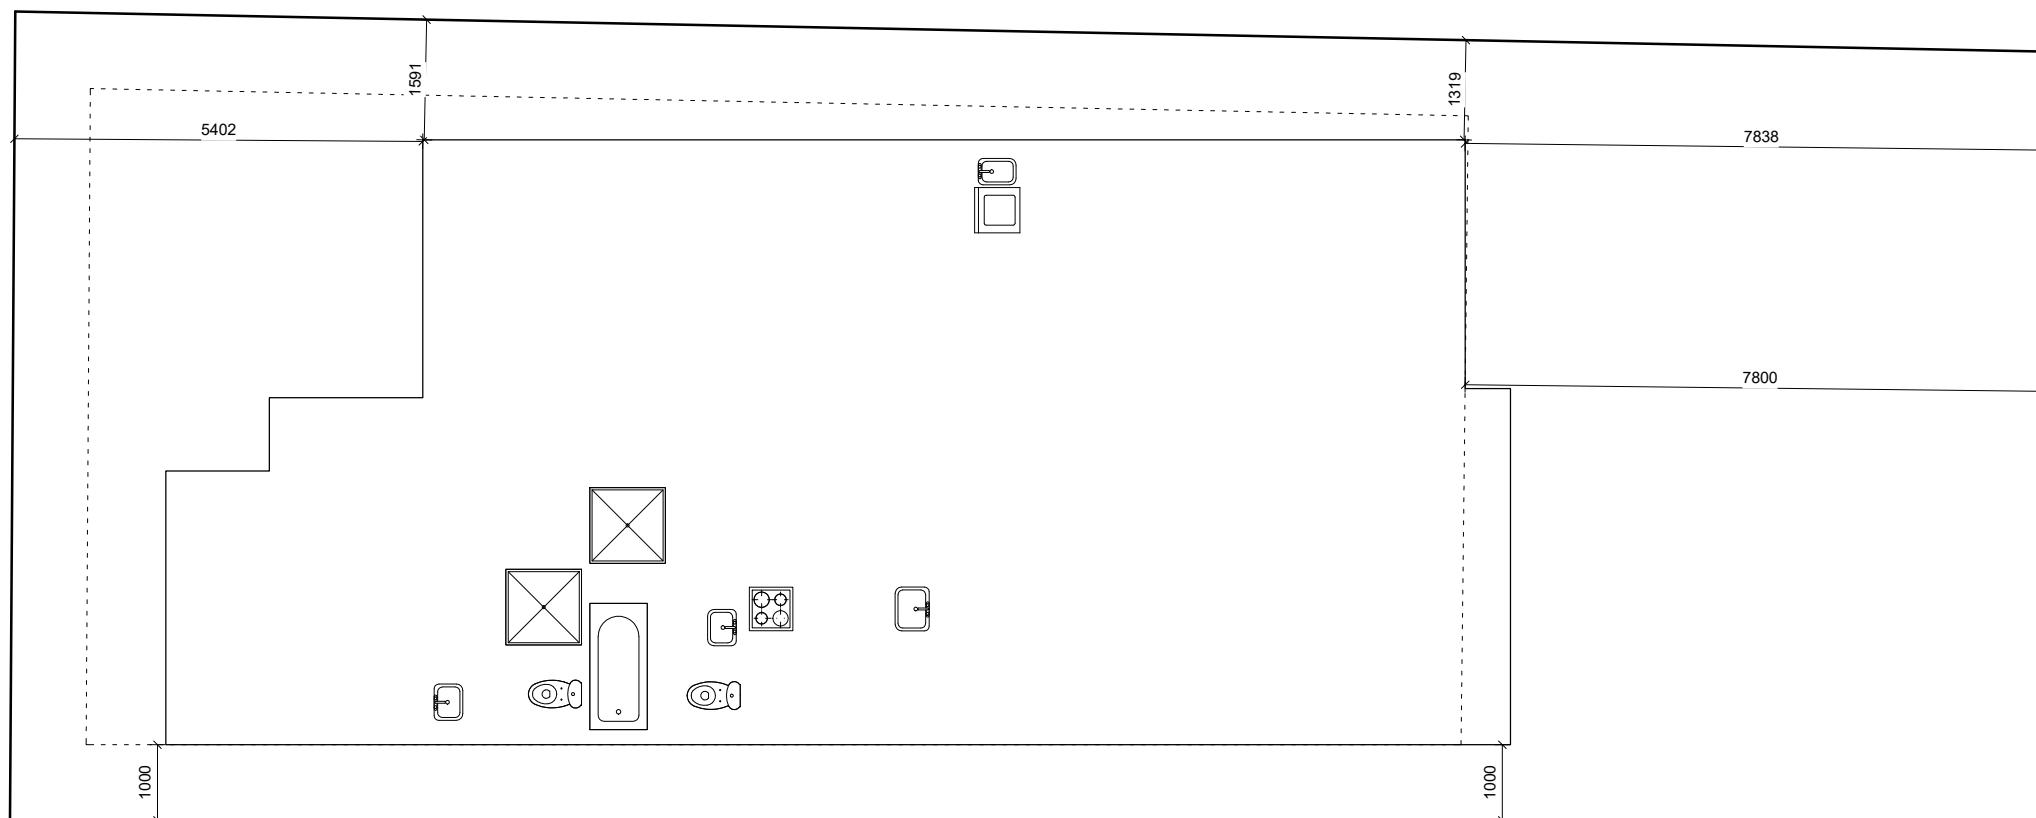

NOTE: ALL DIMENSIONS AND INFORMATION TO BE CONFIRMED ON SITE BY CONTRACTOR

Address: **Kenepuru Subdivision**  
**Proposed 3 Bedroom Stand-Alone**

Drawing: **Lot 142 - Site Plan**

Drawn Date:  
**10.09.2018**

Drawn By:  
**J. Clegg**


Checked By:  
**101 Homes**

Drawn Scale:  
**1 : 100**

Sheet No:  
Revision: **100**




**N** North  
1 : 100

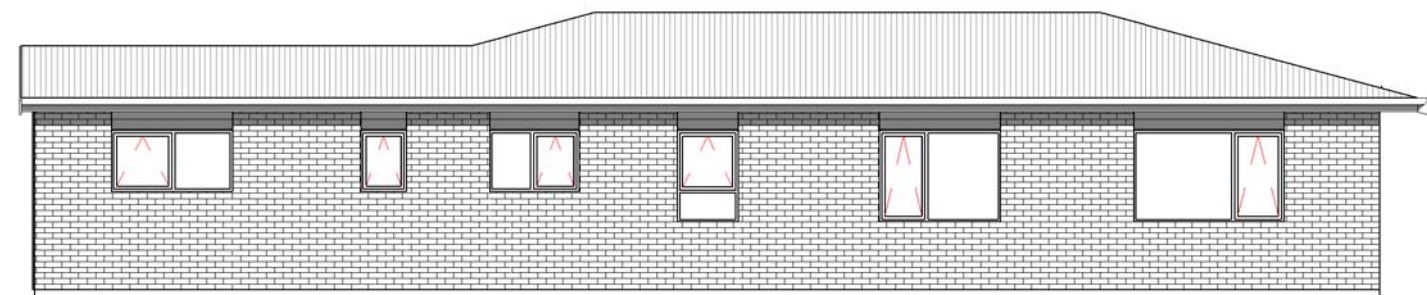

**E** East  
1 : 100



**S** South  
1 : 100

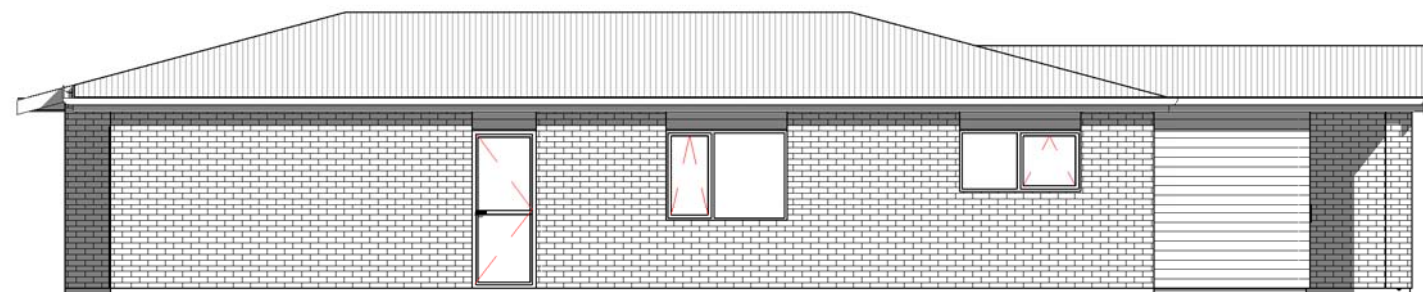

**W** West  
1 : 100

NOTE: ALL DIMENSIONS AND INFORMATION TO BE CONFIRMED ON SITE BY CONTRACTOR

Address: **Kenepuru Subdivision**  
**Proposed 3 Bedroom Stand-Alone**

Drawing: **Lot 142 - Elevations**


Drawn Date:  
10.09.2018

Drawn By:  
J. Clegg

Checked By:  
101 Homes

Drawn Scale:  
1 : 100

Sheet No:  
Revision: **110**

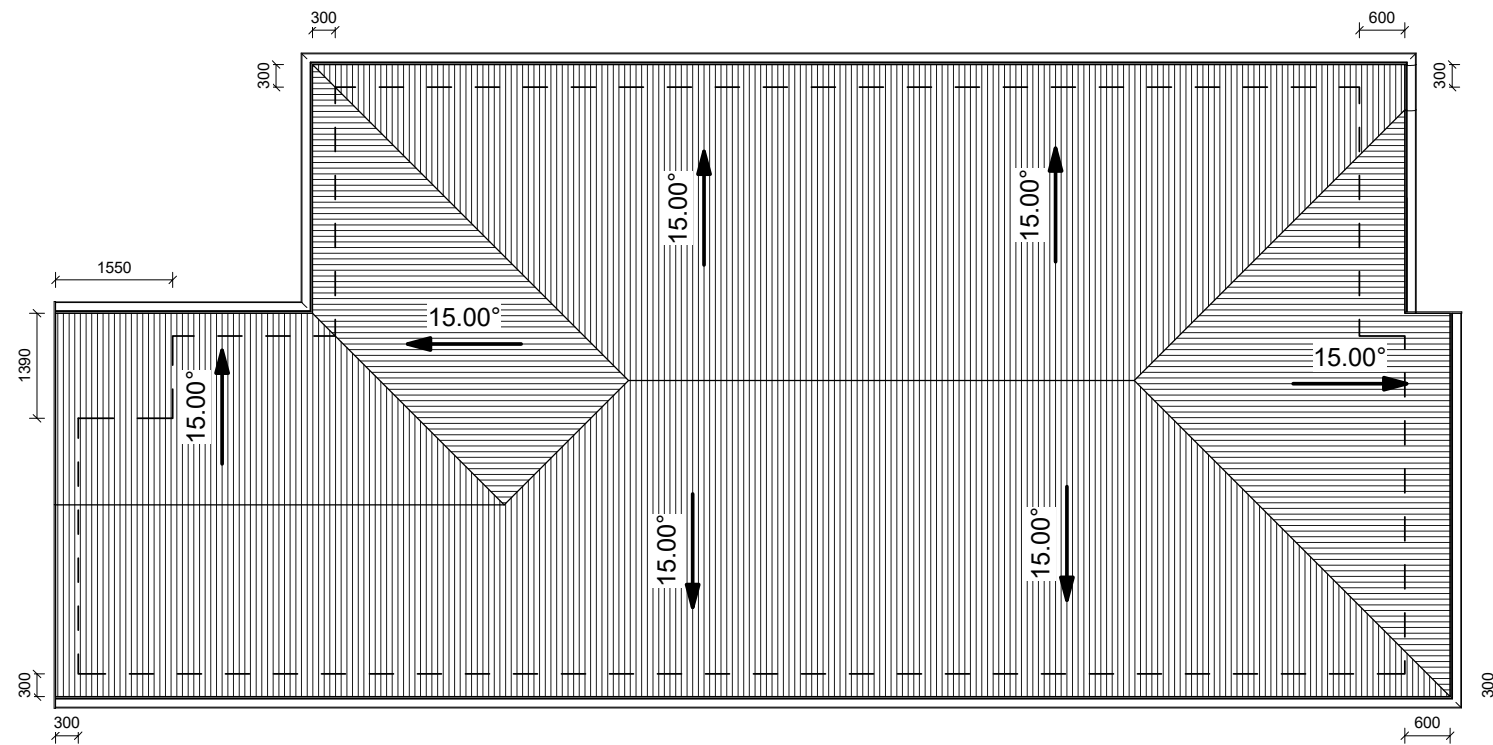

NOTE: ALL DIMENSIONS AND INFORMATION TO BE CONFIRMED ON SITE BY CONTRACTOR

Address: **Kenepuru Subdivision**  
**Proposed 3 Bedroom Stand-Alone**

Drawing: **Lot 142 - Roof Plan**

Drawn Date:  
 10.09.2018


Drawn By:  
 J. Clegg

Checked By:  
 101 Homes

Drawn Scale:  
 1 : 100

Sheet No:  
 Revision: **130**

SYMBOL KEY	
	= LED DOWN LIGHT
	= WALL LIGHT
	= POWER OUTLET (DOUBLE, SWITCHED)
	= APPLIANCE POWER OUTLET
	= SWITCH - NUMBER = NUMBER OF GANGS
	= 3 WAY SWITCH
	= EXTRACTOR FAN
	= SENSOR SWITCH
	= OUTDOOR SENSOR
	= ALARM SENSOR
	= ALARM PANEL
	= ALARM KEYPAD
	= TV/SKY/DATA
	= TV
	= GARAGE DOOR SWITCH
	= DATA POINT
	= PHOTOELECTRIC SMOKE DETECTOR AS PER NZBC:F7
	= COMBINATION SWITCH & METER BOARD
	= DATA, TV, PHONE ETC HUB

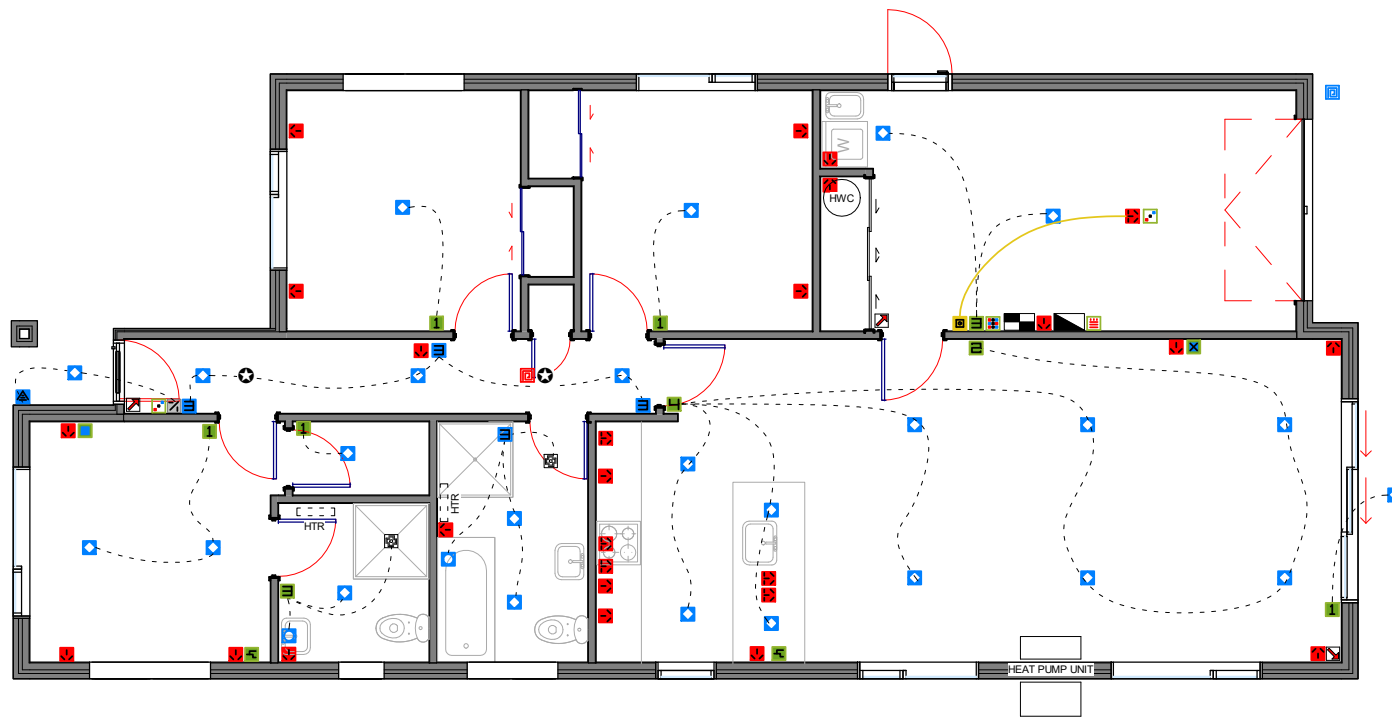

NOTE: ALL DIMENSIONS AND INFORMATION TO BE CONFIRMED ON SITE BY CONTRACTOR

Address: **Kenepuru Subdivision**  
**Proposed 3 Bedroom Stand-Alone**

Drawing: **Lot 142 - Electrical Plan**

Drawn Date:  
10.09.2018

Drawn By:  
J. Clegg

Checked By:  
101 Homes

Drawn Scale:  
1 : 100

Sheet No:  
Revision: **190**