

NOTE: ALL DIMENSIONS AND INFORMATION TO BE CONFIRMED ON SITE BY CONTRACTOR

Address: **Kenepuru Subdivision**
Proposed 3 Bedroom Stand-Alone

Drawing: **Lot 97 - Proposed New Dwelling**
Gross Floor Area: 126.769m²


Drawn Date:
10.09.2018

Drawn By:
J. Clegg

Checked By:
101 Homes

Drawn Scale:
1 : 100

Sheet No:
Revision: **000**

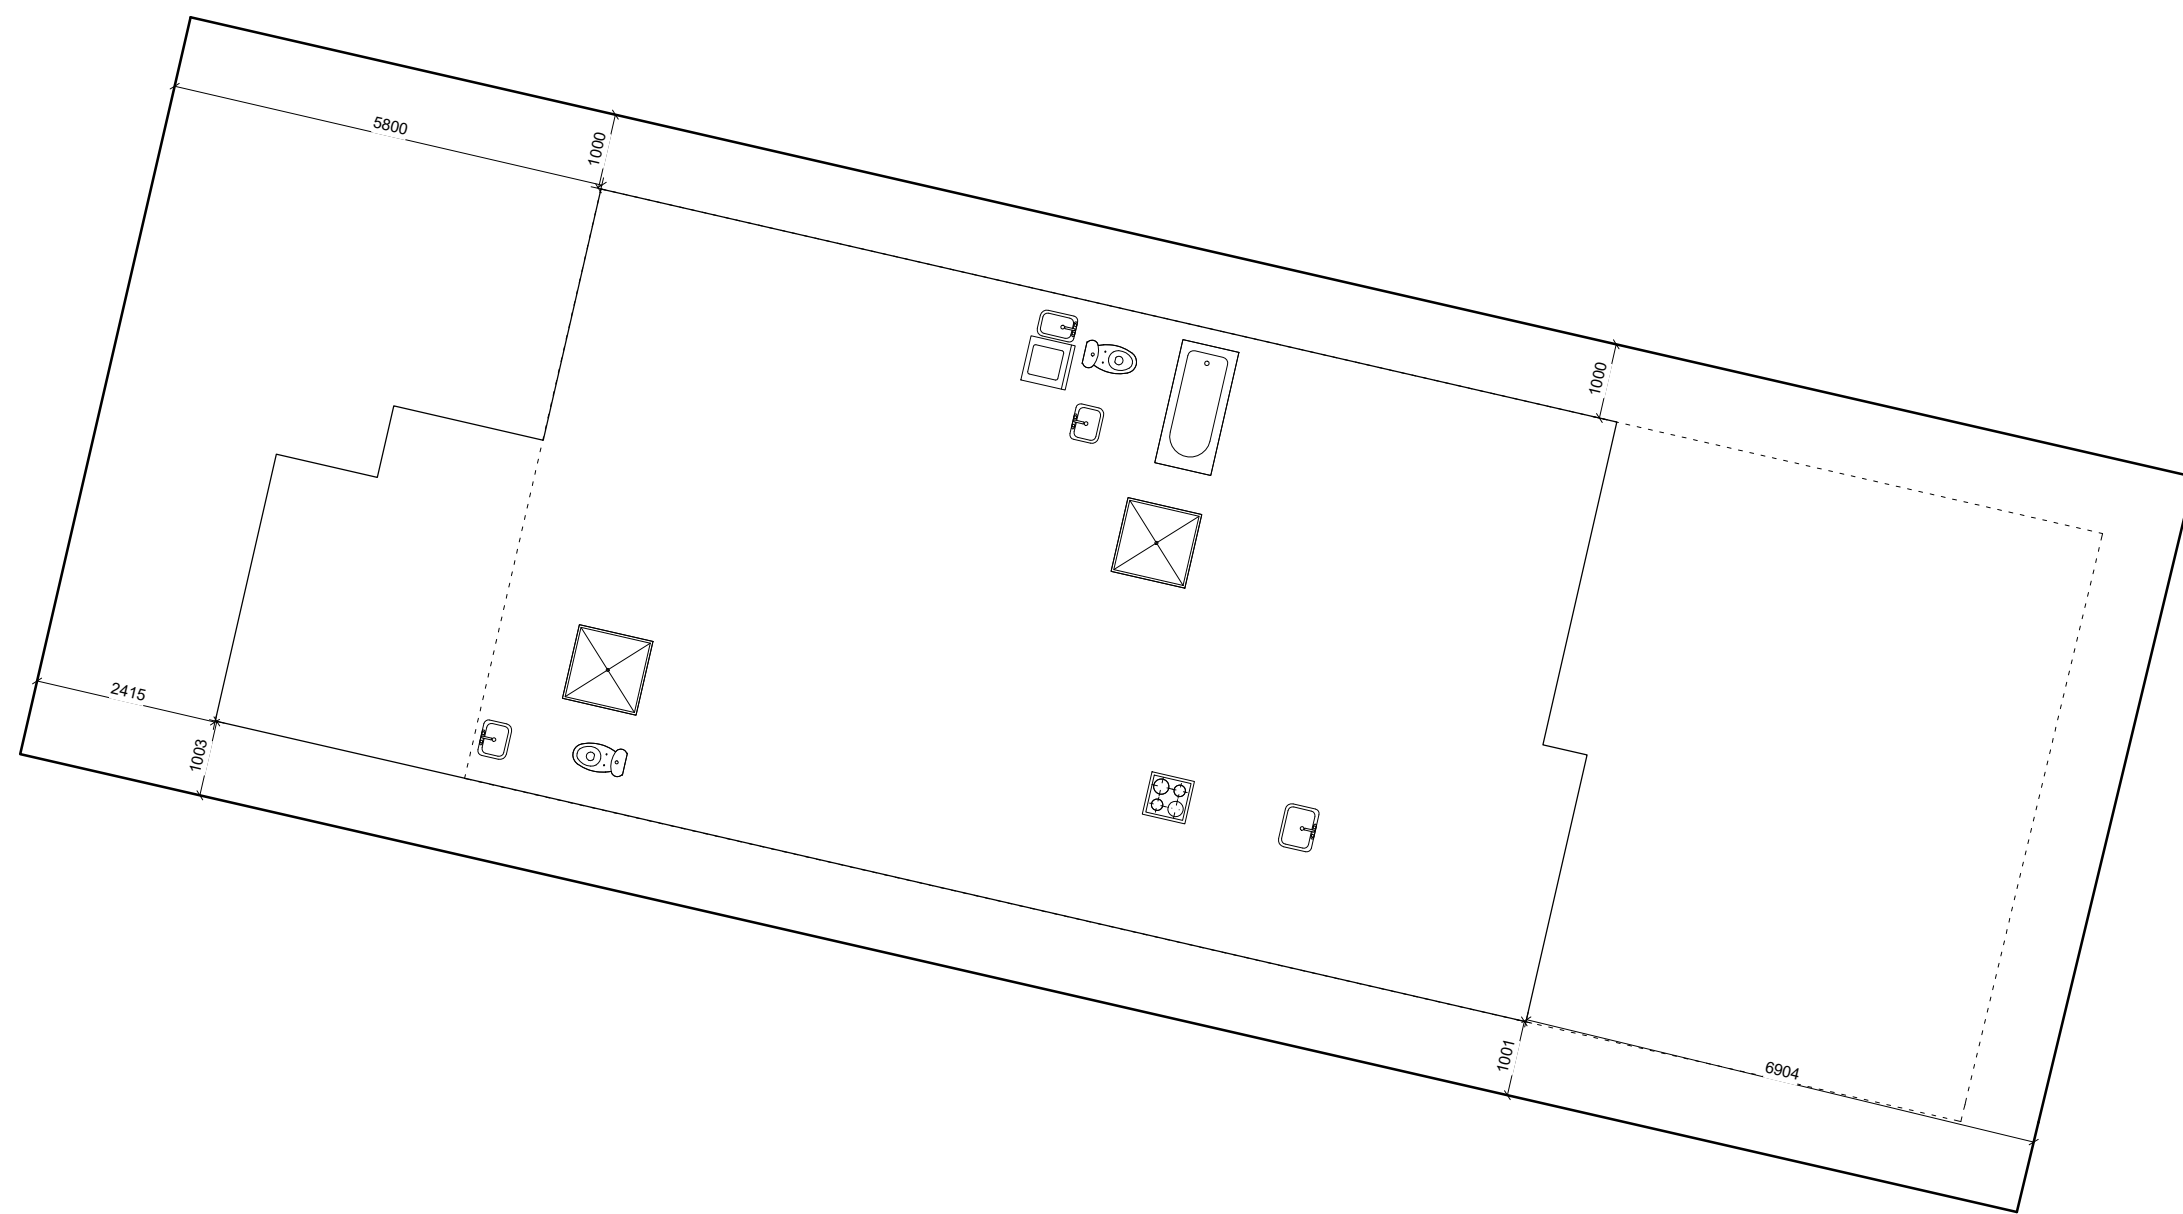

NOTE: ALL DIMENSIONS AND INFORMATION TO BE CONFIRMED ON SITE BY CONTRACTOR

Address: **Kenepuru Subdivision**
Proposed 3 Bedroom Stand-Alone

Drawing: **Lot 97 - Site Plan**

Drawn Date:
10.09.2018

Drawn By:
J. Clegg


Checked By:
101 Homes

Drawn Scale:
1 : 100

Sheet No:
Revision: **100**




N North
1 : 100

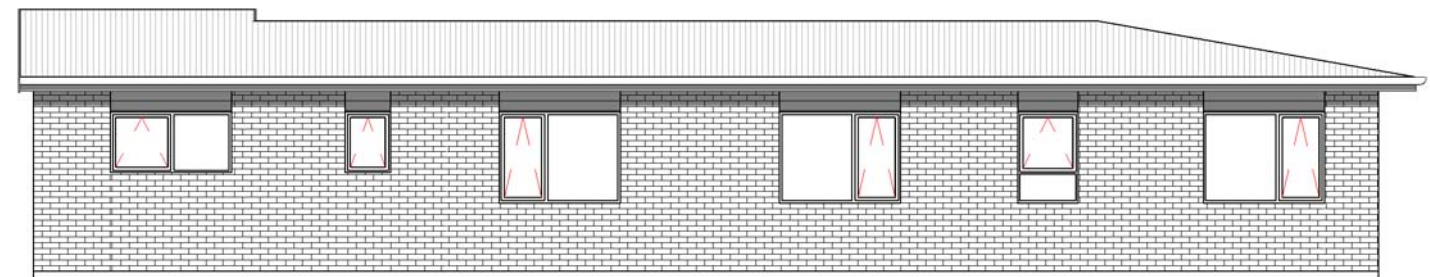

E East
1 : 100



S South
1 : 100

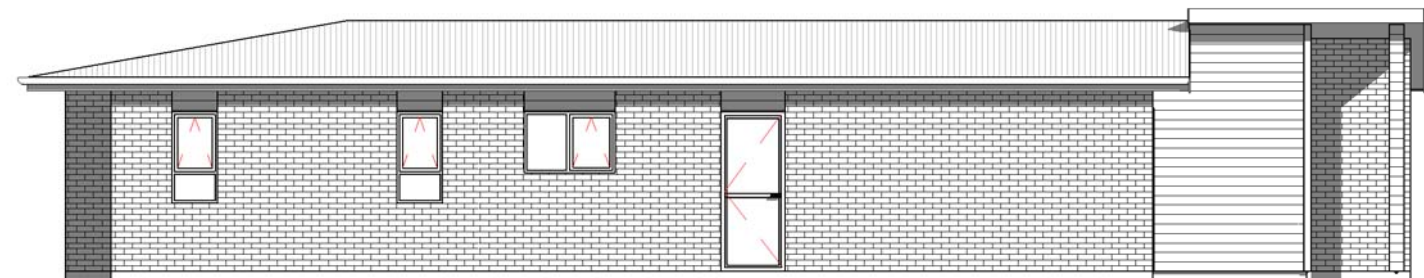

W West
1 : 100

NOTE: ALL DIMENSIONS AND INFORMATION TO BE CONFIRMED ON SITE BY CONTRACTOR

Address: **Kenepuru Subdivision**
Proposed 3 Bedroom Stand-Alone

Drawing: **Lot 97 - Elevations**


Drawn Date:
10.09.2018

Drawn By:
J. Clegg

Checked By:
101 Homes

Drawn Scale:
1 : 100

Sheet No:
Revision: **110**

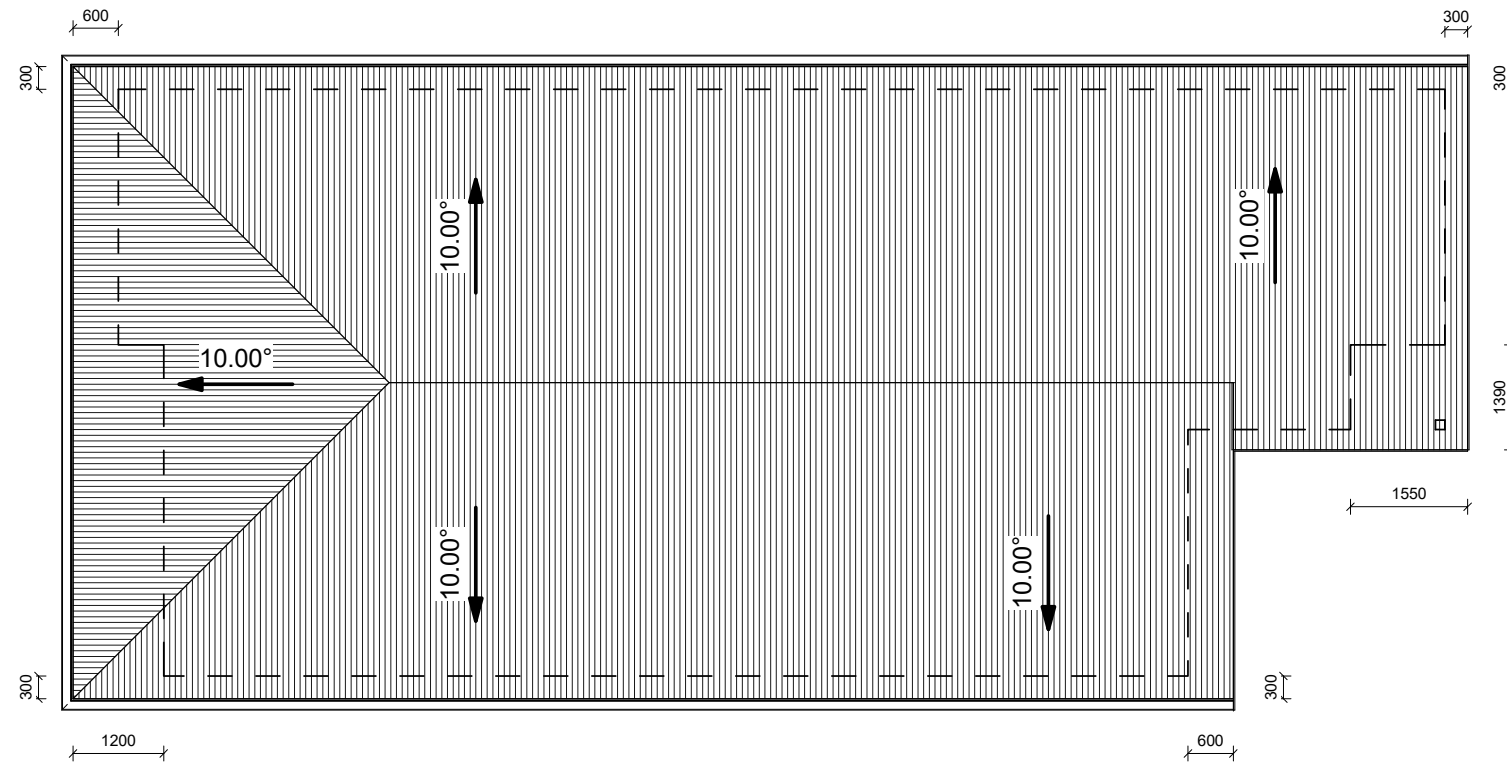

NOTE: ALL DIMENSIONS AND INFORMATION TO BE CONFIRMED ON SITE BY CONTRACTOR

Address: **Kenepuru Subdivision**
Proposed 3 Bedroom Stand-Alone

Drawing: **Lot 97 - Roof Plan**




















Drawn Date:
10.09.2018


Drawn By:
J. Clegg

Checked By:
101 Homes

Drawn Scale:
1 : 100

Sheet No:
 Revision: **130**

SYMBOL KEY	
	= LED DOWN LIGHT
	= WALL LIGHT
	= POWER OUTLET (DOUBLE, SWITCHED)
	= APPLIANCE POWER OUTLET
	= SWITCH -NUMBER = NUMBER OF GANGS
	= 3 WAY SWITCH
	= EXTRACTOR FAN
	= SENSOR SWITCH
	= OUTDOOR SENSOR
	= ALARM SENSOR
	= ALARM PANEL
	= ALARM KEYPAD
	= TV/SKY/DATA
	= TV
	= GARAGE DOOR SWITCH
	= DATA POINT
	= PHOTOELECTRIC SMOKE DETECTOR AS PER NZBC:F7
	= COMBINATION SWITCH & METER BOARD
	= DATA, TV, PHONE ETC HUB

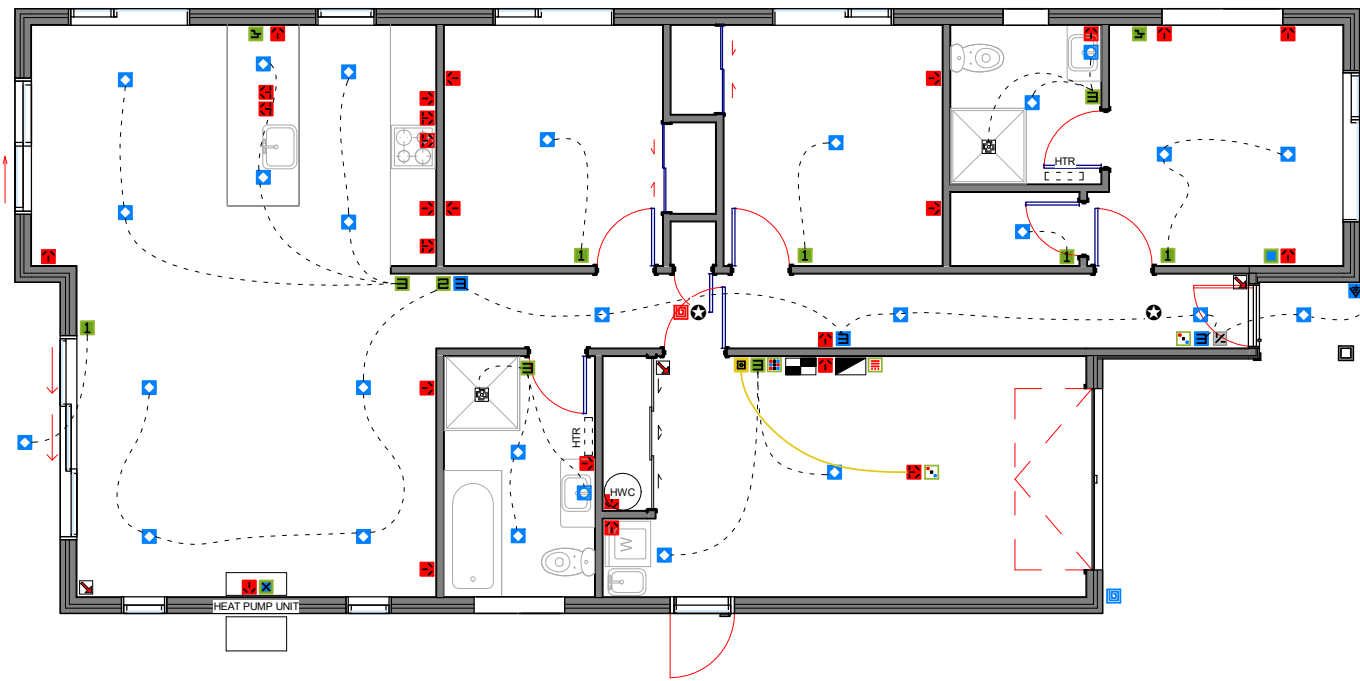

NOTE: ALL DIMENSIONS AND INFORMATION TO BE CONFIRMED ON SITE BY CONTRACTOR

Address: **Kenepuru Subdivision**
Proposed 3 Bedroom Stand-Alone

Drawing: **Lot 97 - Electrical Plan**

Drawn Date:
10.09.2018

Drawn By:
J. Clegg

Checked By:
101 Homes

Drawn Scale:
1 : 100

Sheet No:
Revision: **190**