

NOTE: ALL DIMENSIONS AND INFORMATION TO BE CONFIRMED ON SITE BY CONTRACTOR

Address: **Kenepuru Subdivision**
Proposed 3 Bedroom Stand-Alone

Drawing: **Lot 44 - Proposed New Dwelling**
 Gross Floor Area: 125.823m²



Drawn Date:
09.09.2018

Drawn By:
J. Clegg

Checked By:
101 Homes

Drawn Scale:
1 : 100

Sheet No:
 Revision: **000**

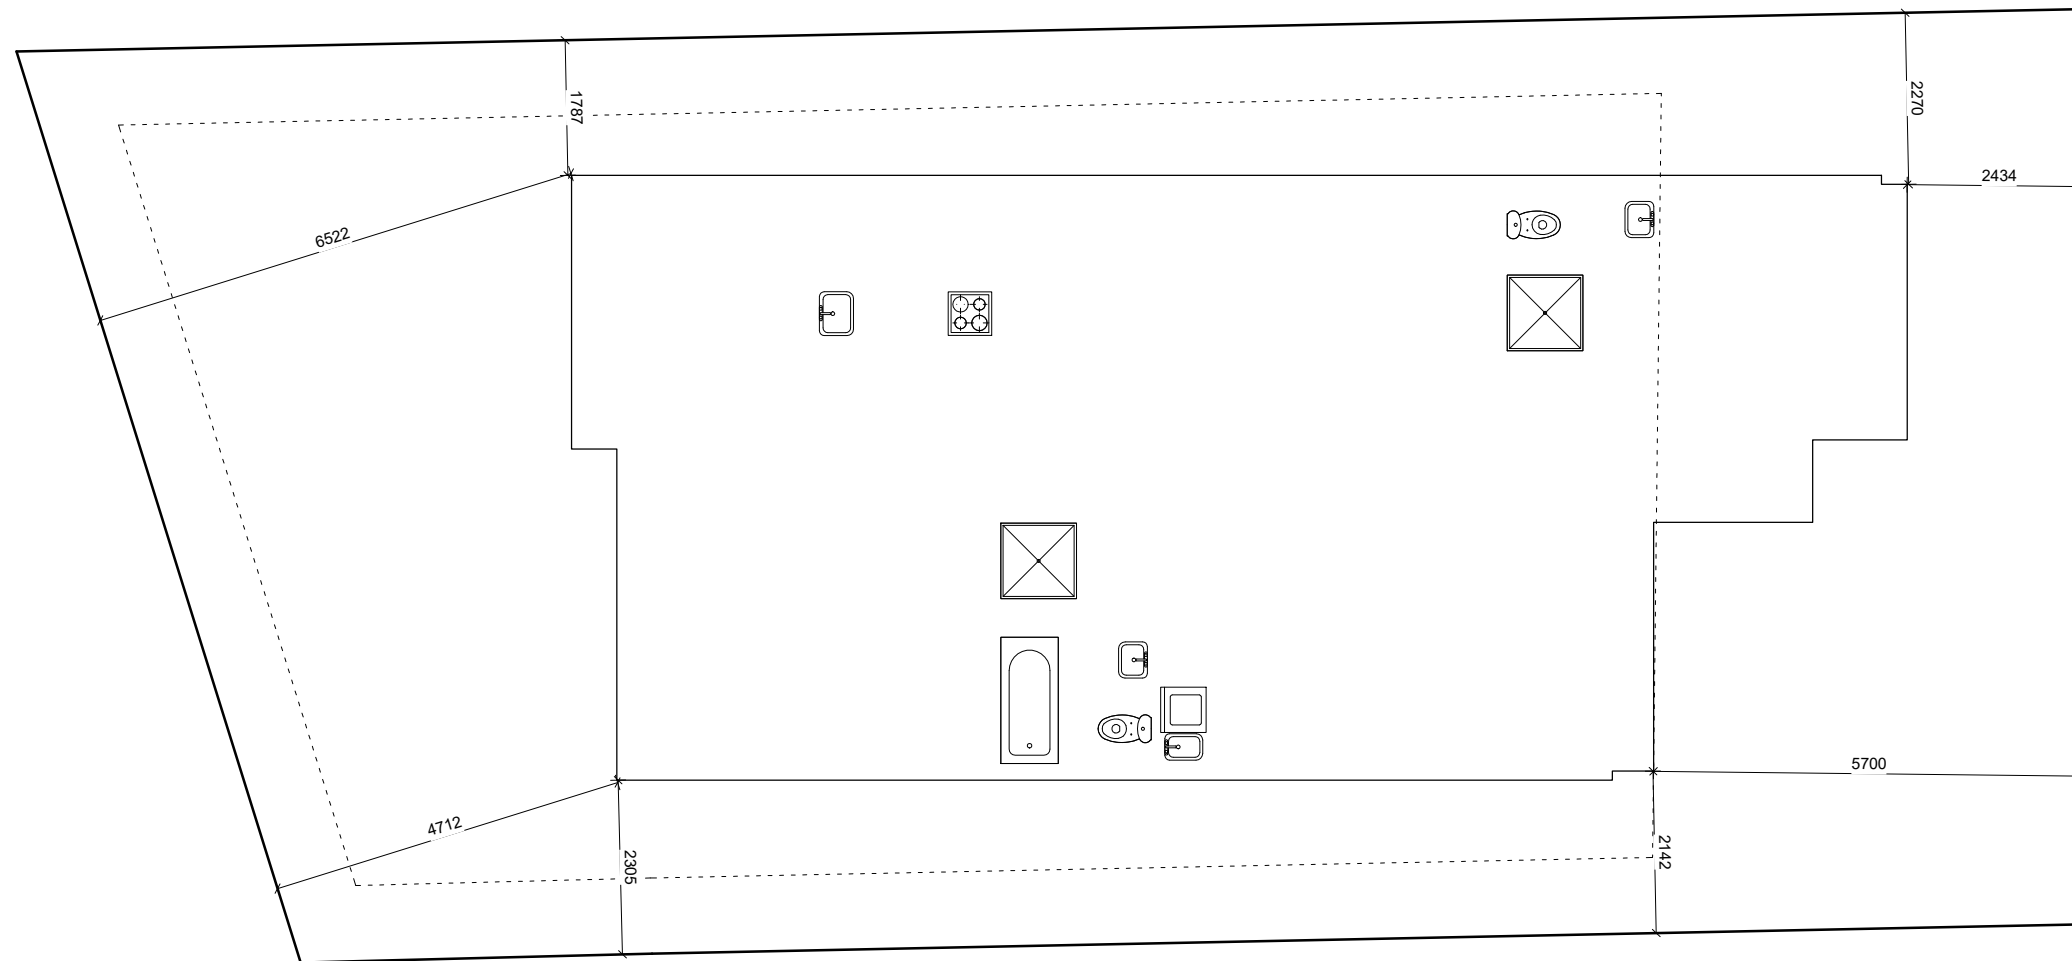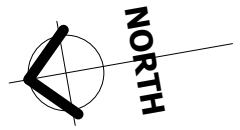

NOTE: ALL DIMENSIONS AND INFORMATION TO BE CONFIRMED ON SITE BY CONTRACTOR

Address: **Kenepuru Subdivision**
Proposed 3 Bedroom Stand-Alone

Drawing: **Lot 44 - Site Plan**

Drawn Date:
09.09.2018

Drawn By:
J. Clegg


Checked By:
101 Homes

Drawn Scale:
1 : 100

Sheet No:
Revision: **100**




N North
1 : 100

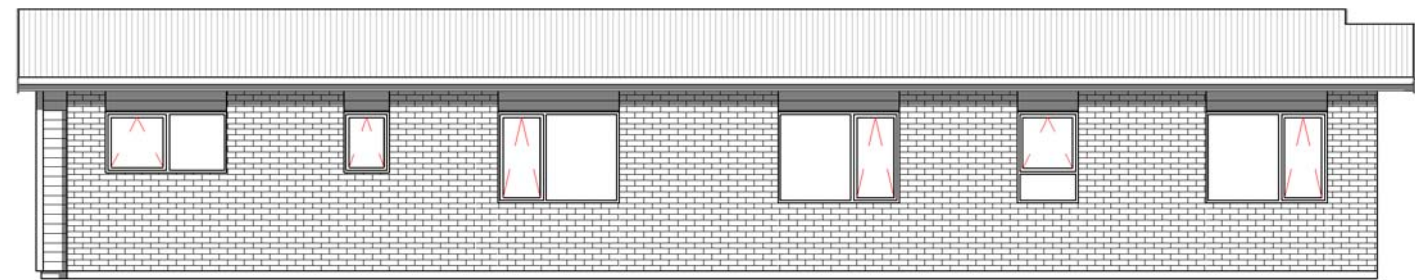

E East
1 : 100



S South
1 : 100

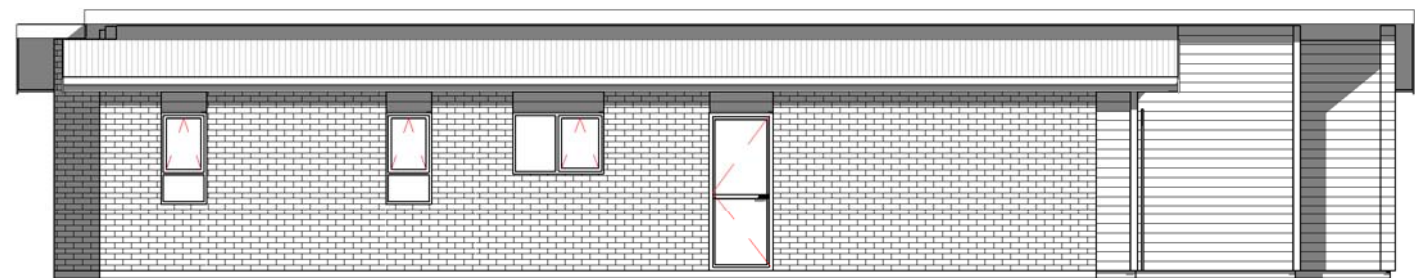

W West
1 : 100

NOTE: ALL DIMENSIONS AND INFORMATION TO BE CONFIRMED ON SITE BY CONTRACTOR

Address: **Kenepuru Subdivision**
Proposed 3 Bedroom Stand-Alone

Drawing: **Lot 44 - Elevations**


Drawn Date:
09.09.2018

Drawn By:
J. Clegg

Checked By:
101 Homes

Drawn Scale:
1 : 100

Sheet No:
Revision: **110**

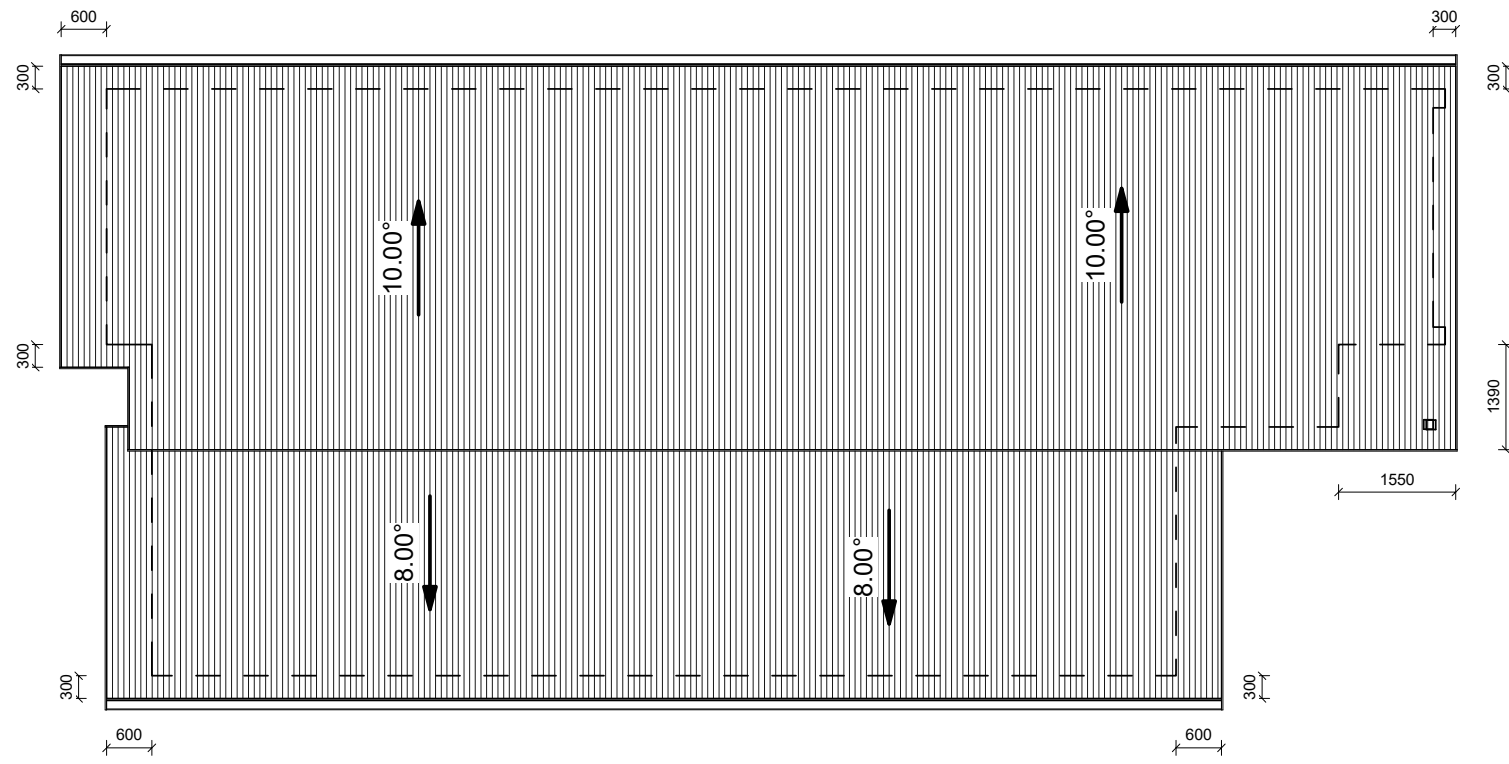

NOTE: ALL DIMENSIONS AND INFORMATION TO BE CONFIRMED ON SITE BY CONTRACTOR

Address: **Kenepuru Subdivision**
Proposed 3 Bedroom Stand-Alone

Drawing: **Lot 44 - Roof Plan**


















 

Drawn Date:
09.09.2018


Drawn By:
J. Clegg

Checked By:
101 Homes

Drawn Scale:
1 : 100

Sheet No:
 Revision: **130**

SYMBOL KEY	
	= LED DOWN LIGHT
	= WALL LIGHT
	= POWER OUTLET (DOUBLE, SWITCHED)
	= APPLIANCE POWER OUTLET
	= SWITCH -NUMBER = NUMBER OF GANGS
	= 3 WAY SWITCH
	= EXTRACTOR FAN
	= SENSOR SWITCH
	= OUTDOOR SENSOR
	= ALARM SENSOR
	= ALARM PANEL
	= ALARM KEYPAD
	= TV/SKY/DATA
	= TV
	= GARAGE DOOR SWITCH
	= DATA POINT
	= PHOTOELECTRIC SMOKE DETECTOR AS PER NZBC:F7
	= COMBINATION SWITCH & METER BOARD
	= DATA, TV, PHONE ETC HUB

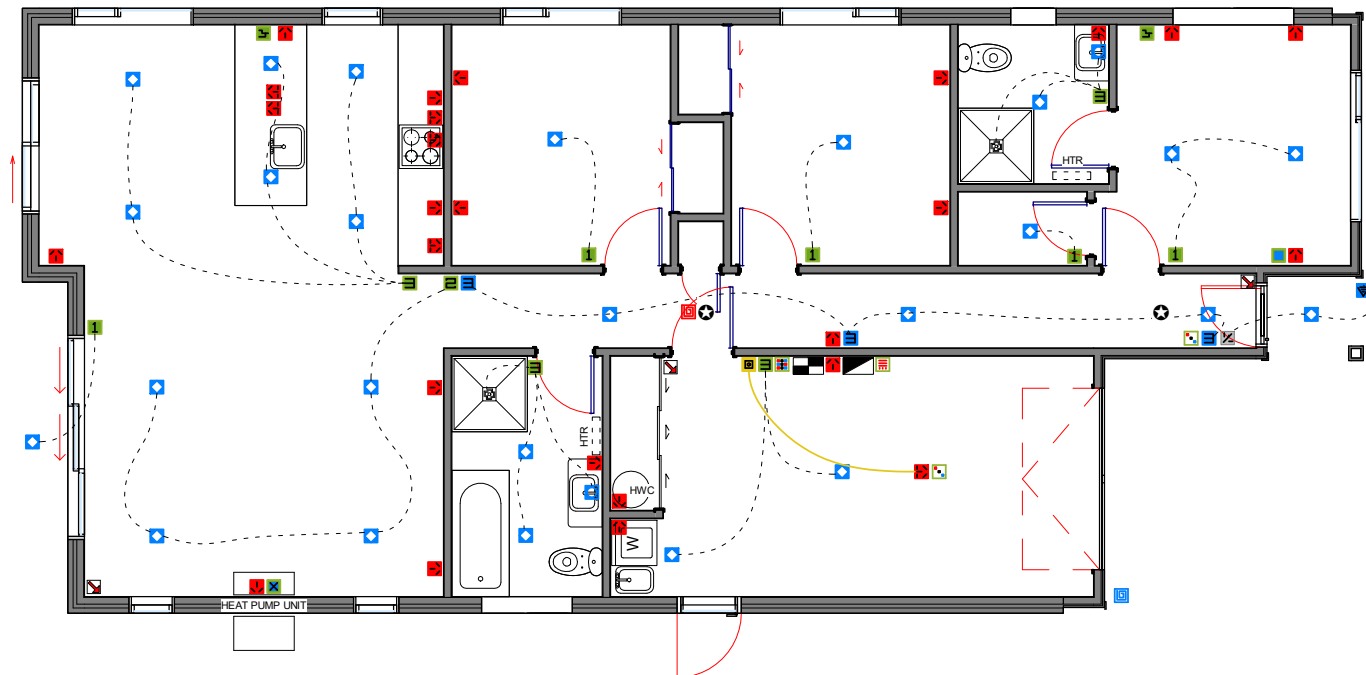

NOTE: ALL DIMENSIONS AND INFORMATION TO BE CONFIRMED ON SITE BY CONTRACTOR

Address: Kenepuru Subdivision Proposed 3 Bedroom Stand-Alone	Drawing: Lot 44 - Electrical Plan	Drawn Date: 09.09.2018	Drawn By: J. Clegg	Checked By: 101 Homes	Drawn Scale: 1 : 100	Sheet No: Revision: 190
---	--	----------------------------------	------------------------------	---------------------------------	--------------------------------	-----------------------------------